



POLE MOUNTED TRANSFORMER DETAIL

NO SCALE: ED-01

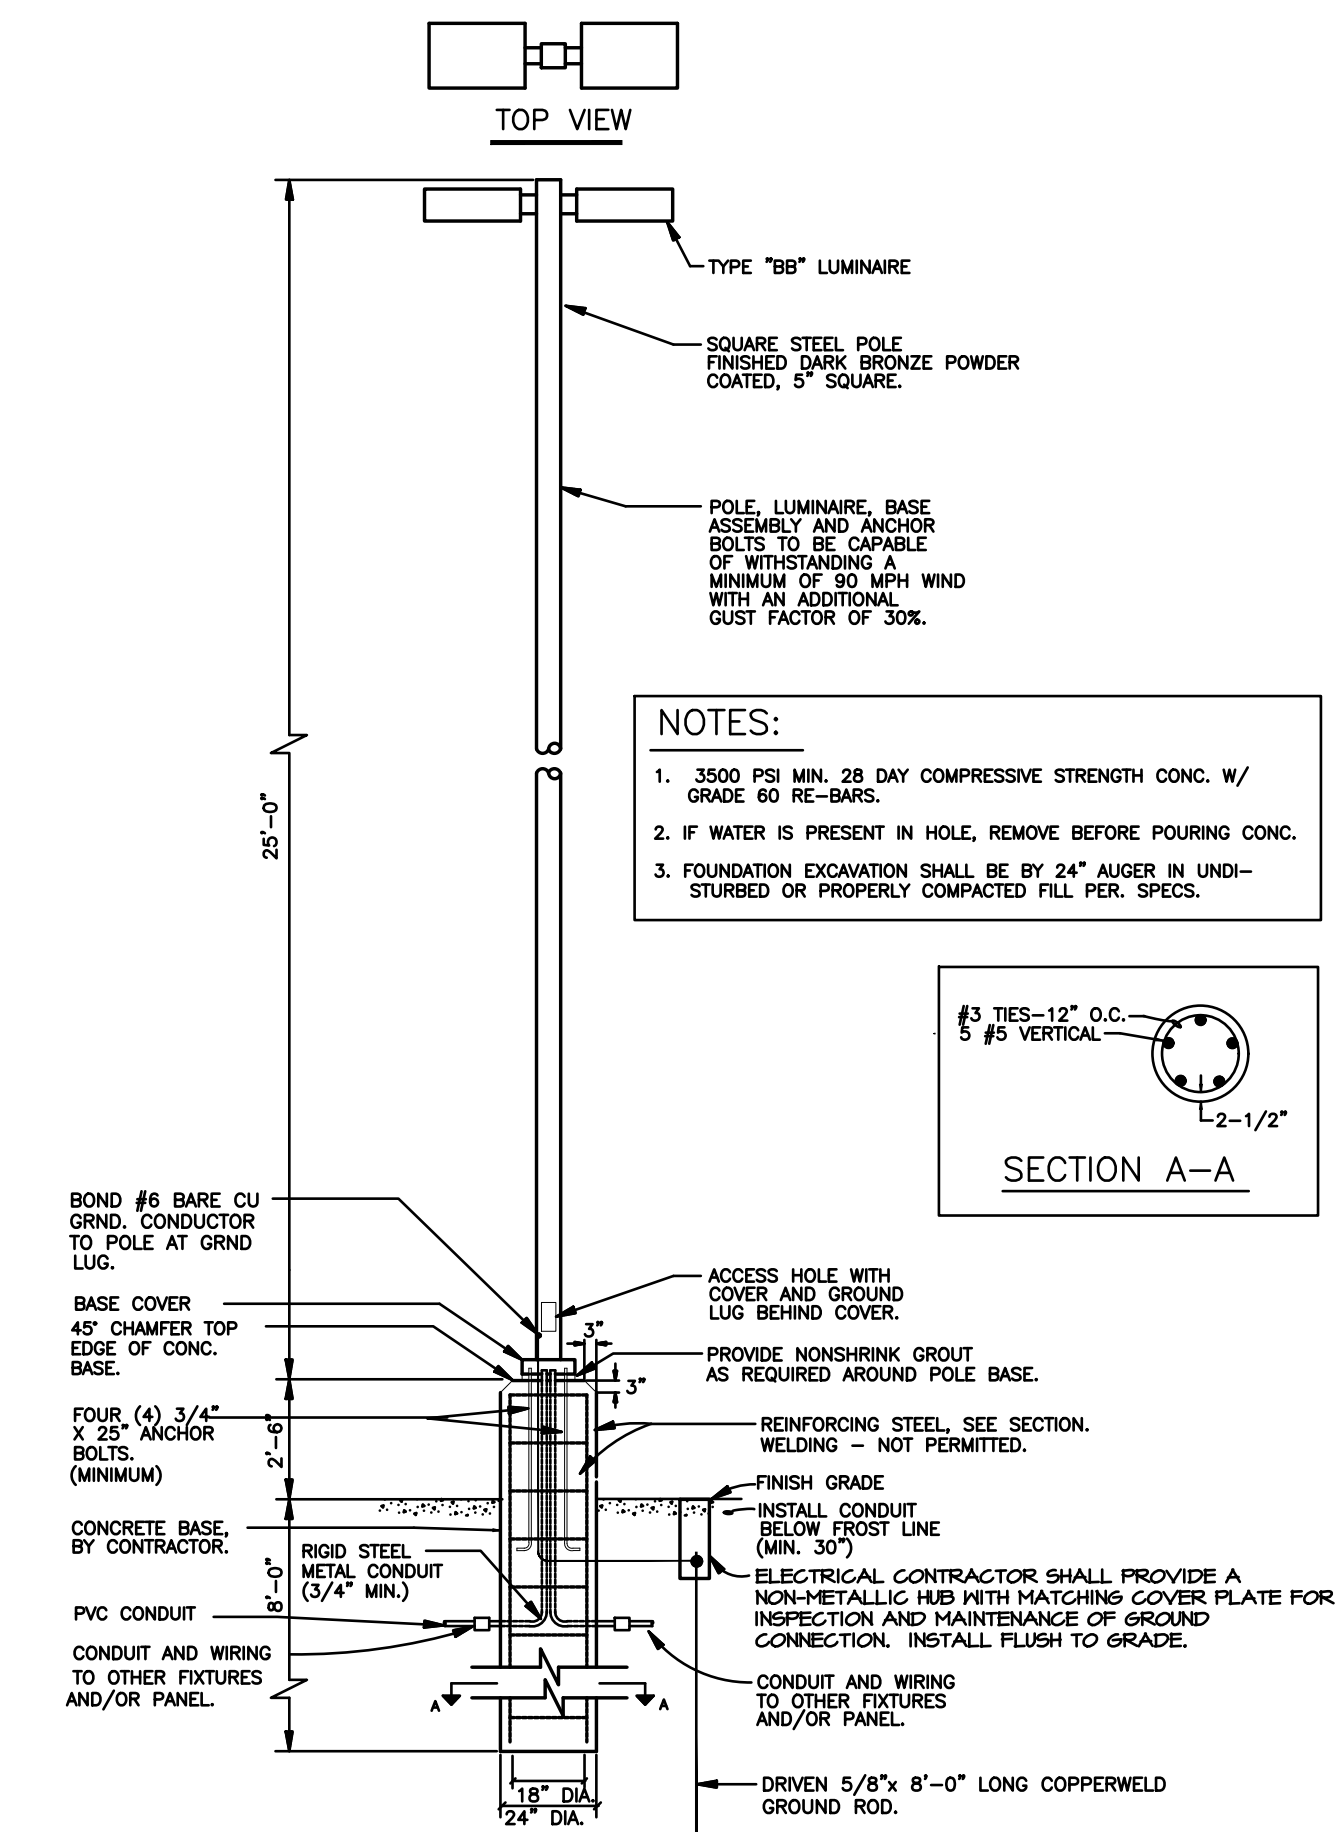


LIGHTING STANDARD DETAIL

NO SCALE: ED-18

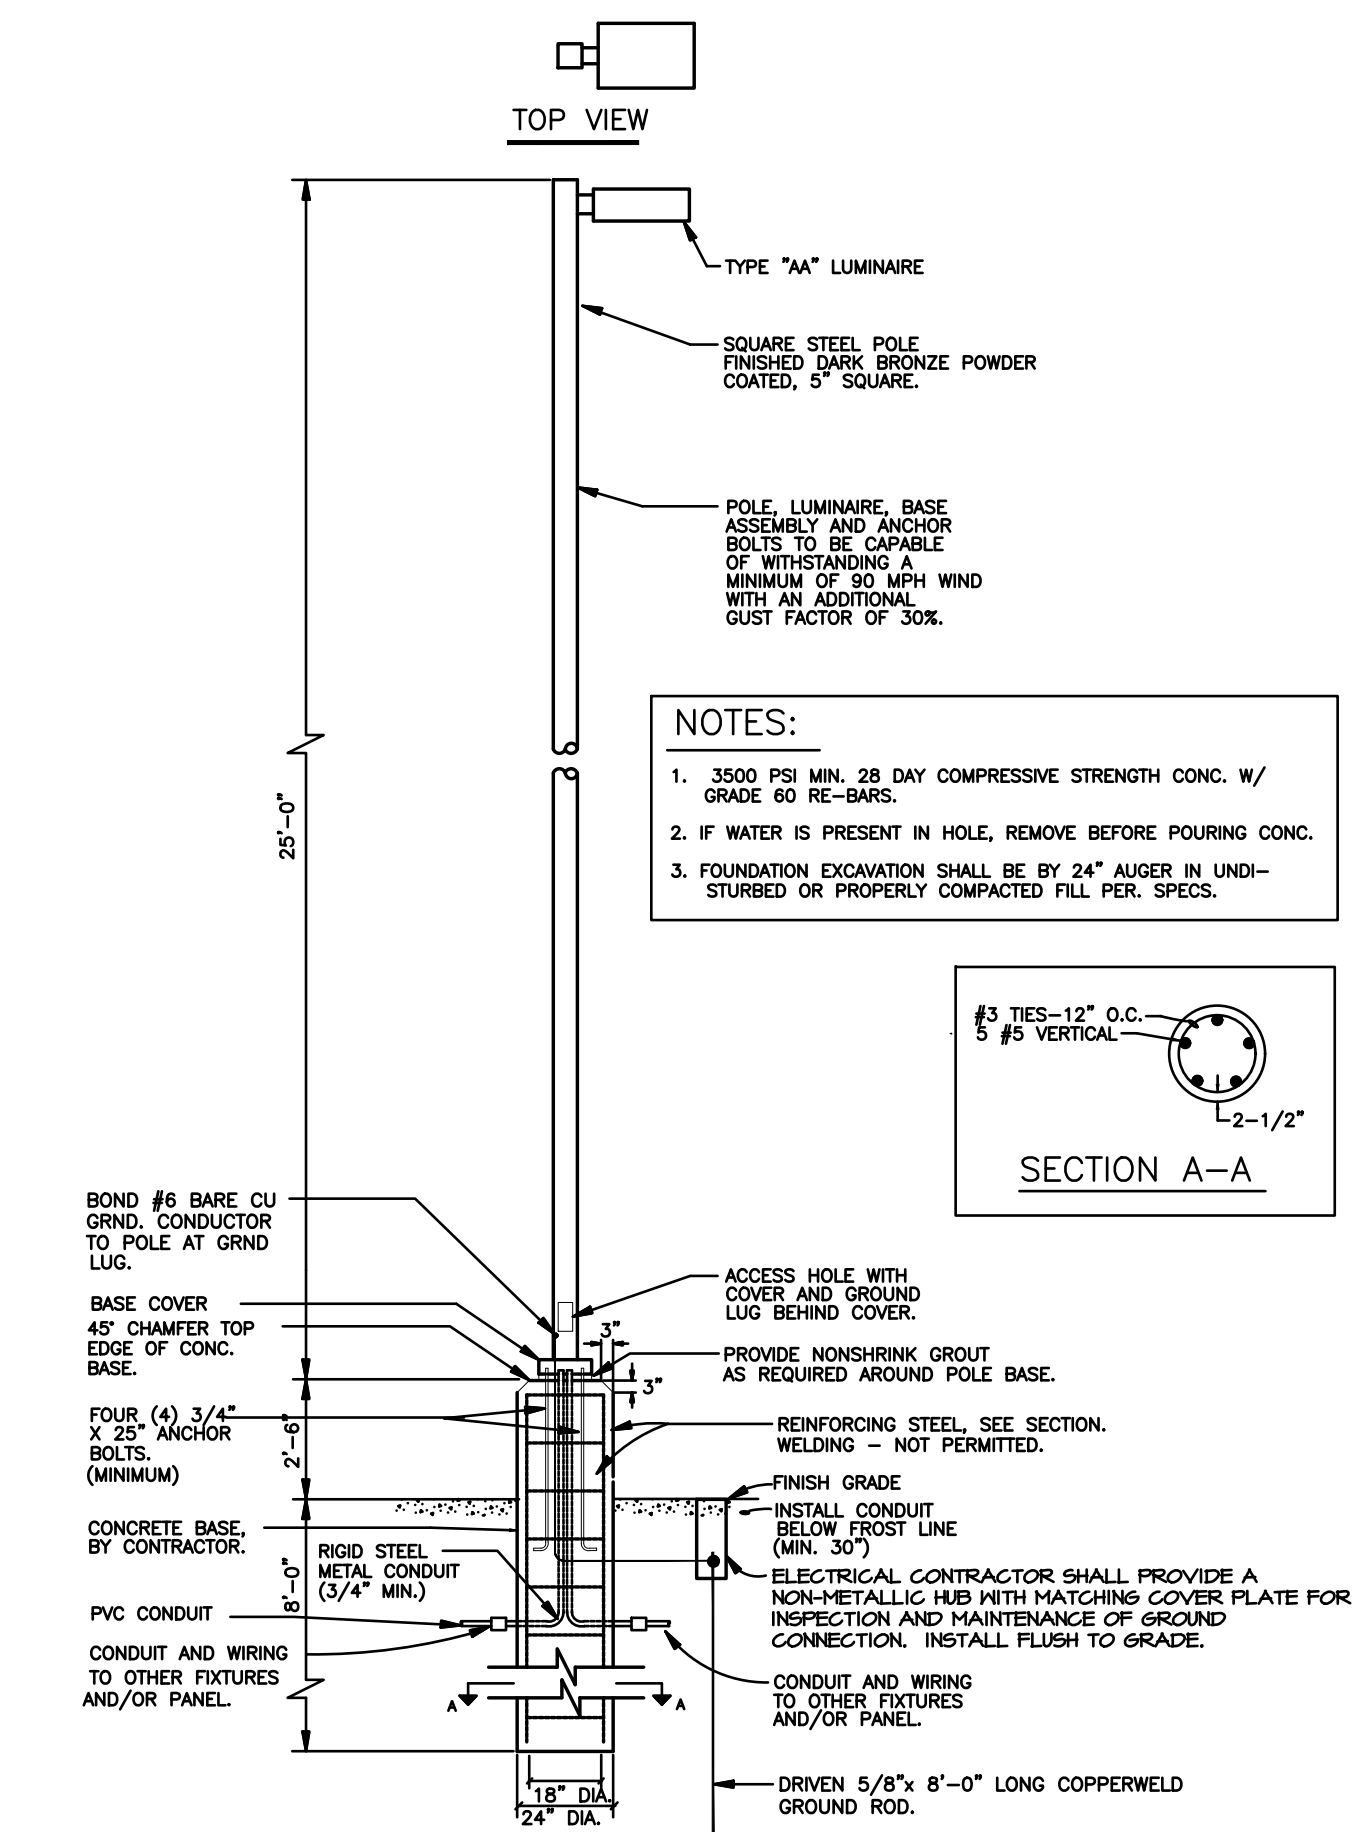

LIGHTING STANDARD DETAIL

NO SCALE: ED-18

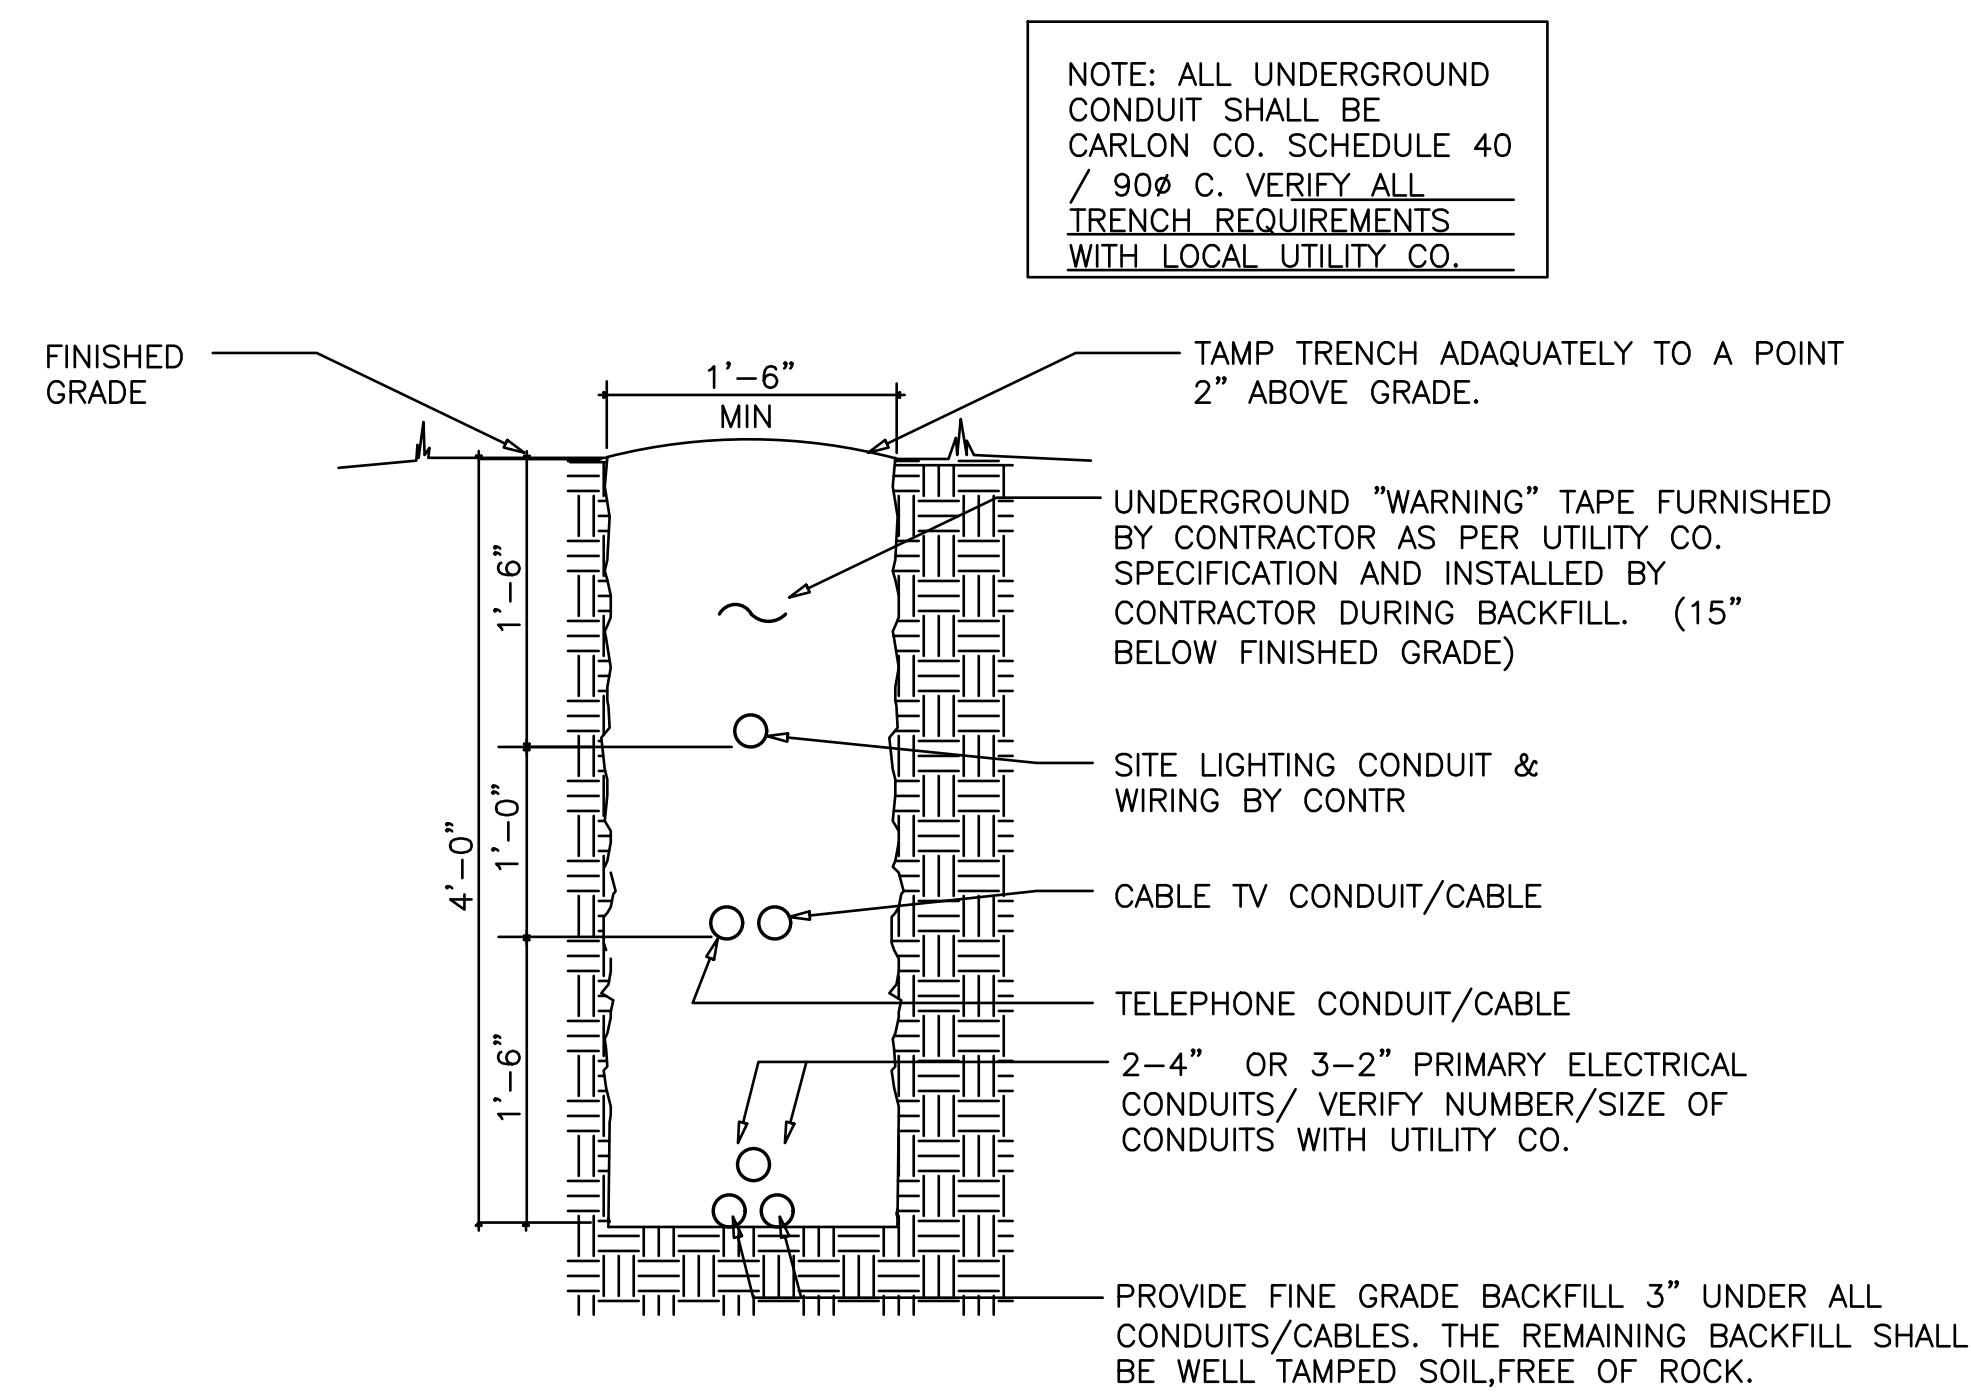


ELECTRICAL UTILITY TRENCH DETAIL

SCALE: 3/4" = 1'-0" ED-04

NOTE: ALL UNDERGROUND CONDUIT SHALL BE CARLON CO. SCHEDULE 40 / 90# C. VERIFY ALL TRENCH REQUIREMENTS WITH LOCAL UTILITY CO.

STORAGE FACILITY DEVELOPMENT
305 WEST ECONOMY ROAD
MORRISTOWN, TN. 37814
MR. BARAK ZUKERMAN
23025

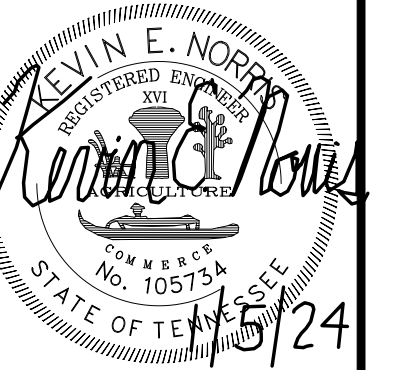

R. LEN JOHNSON & ASSOCIATES
Architects, Construction Analysts & Inspectors
724 TAYLOR ROAD, KNOXVILLE, TN 37920 (VOL) 573-1148

Drawing Description: SITE PLAN DETAILS

REVISIONS	
No.	Date

Plot Scale: AS NOTED
Dwn: KN
Appd: KN
Project No: 23046
Date: 5 JAN 24

Sh. No. _____
of _____

E1.2
of 6

NORRIS & ASSOCIATES ENGINEERS INC.
5518 WALLWOOD ROAD
KNOXVILLE, TN 37912
PHONE: 865-584-3063
FAX: 865-584-3065
www.norrisandassociates.com

THIS DRAWING IS GENERALLY DIAGRAMMATIC AND EXCEPT WHERE SPECIFICALLY DIMENSIONED OR DETAILED, INDICATES THE GENERAL ARRANGEMENT OF THE WORK. THE CONTRACTOR SHALL INSTALL HIS WORK TO CONFORM AS NEARLY AS POSSIBLE TO THE LOCATIONS AND ARRANGEMENTS SHOWN COORDINATE THE WORK WITH ALL OTHER TRADES TO AVOID INTERFERENCE.

THIS DRAWING AND ITS CONTENTS ARE THE PROPERTY OF NORRIS & ASSOCIATES ENGINEERS INC. AND SHALL NOT BE REPRODUCED IN WHOLE OR IN PART WITHOUT THE EXPRESS WRITTEN AUTHORIZATION OF NORRIS & ASSOCIATES ENGINEERS INC.